

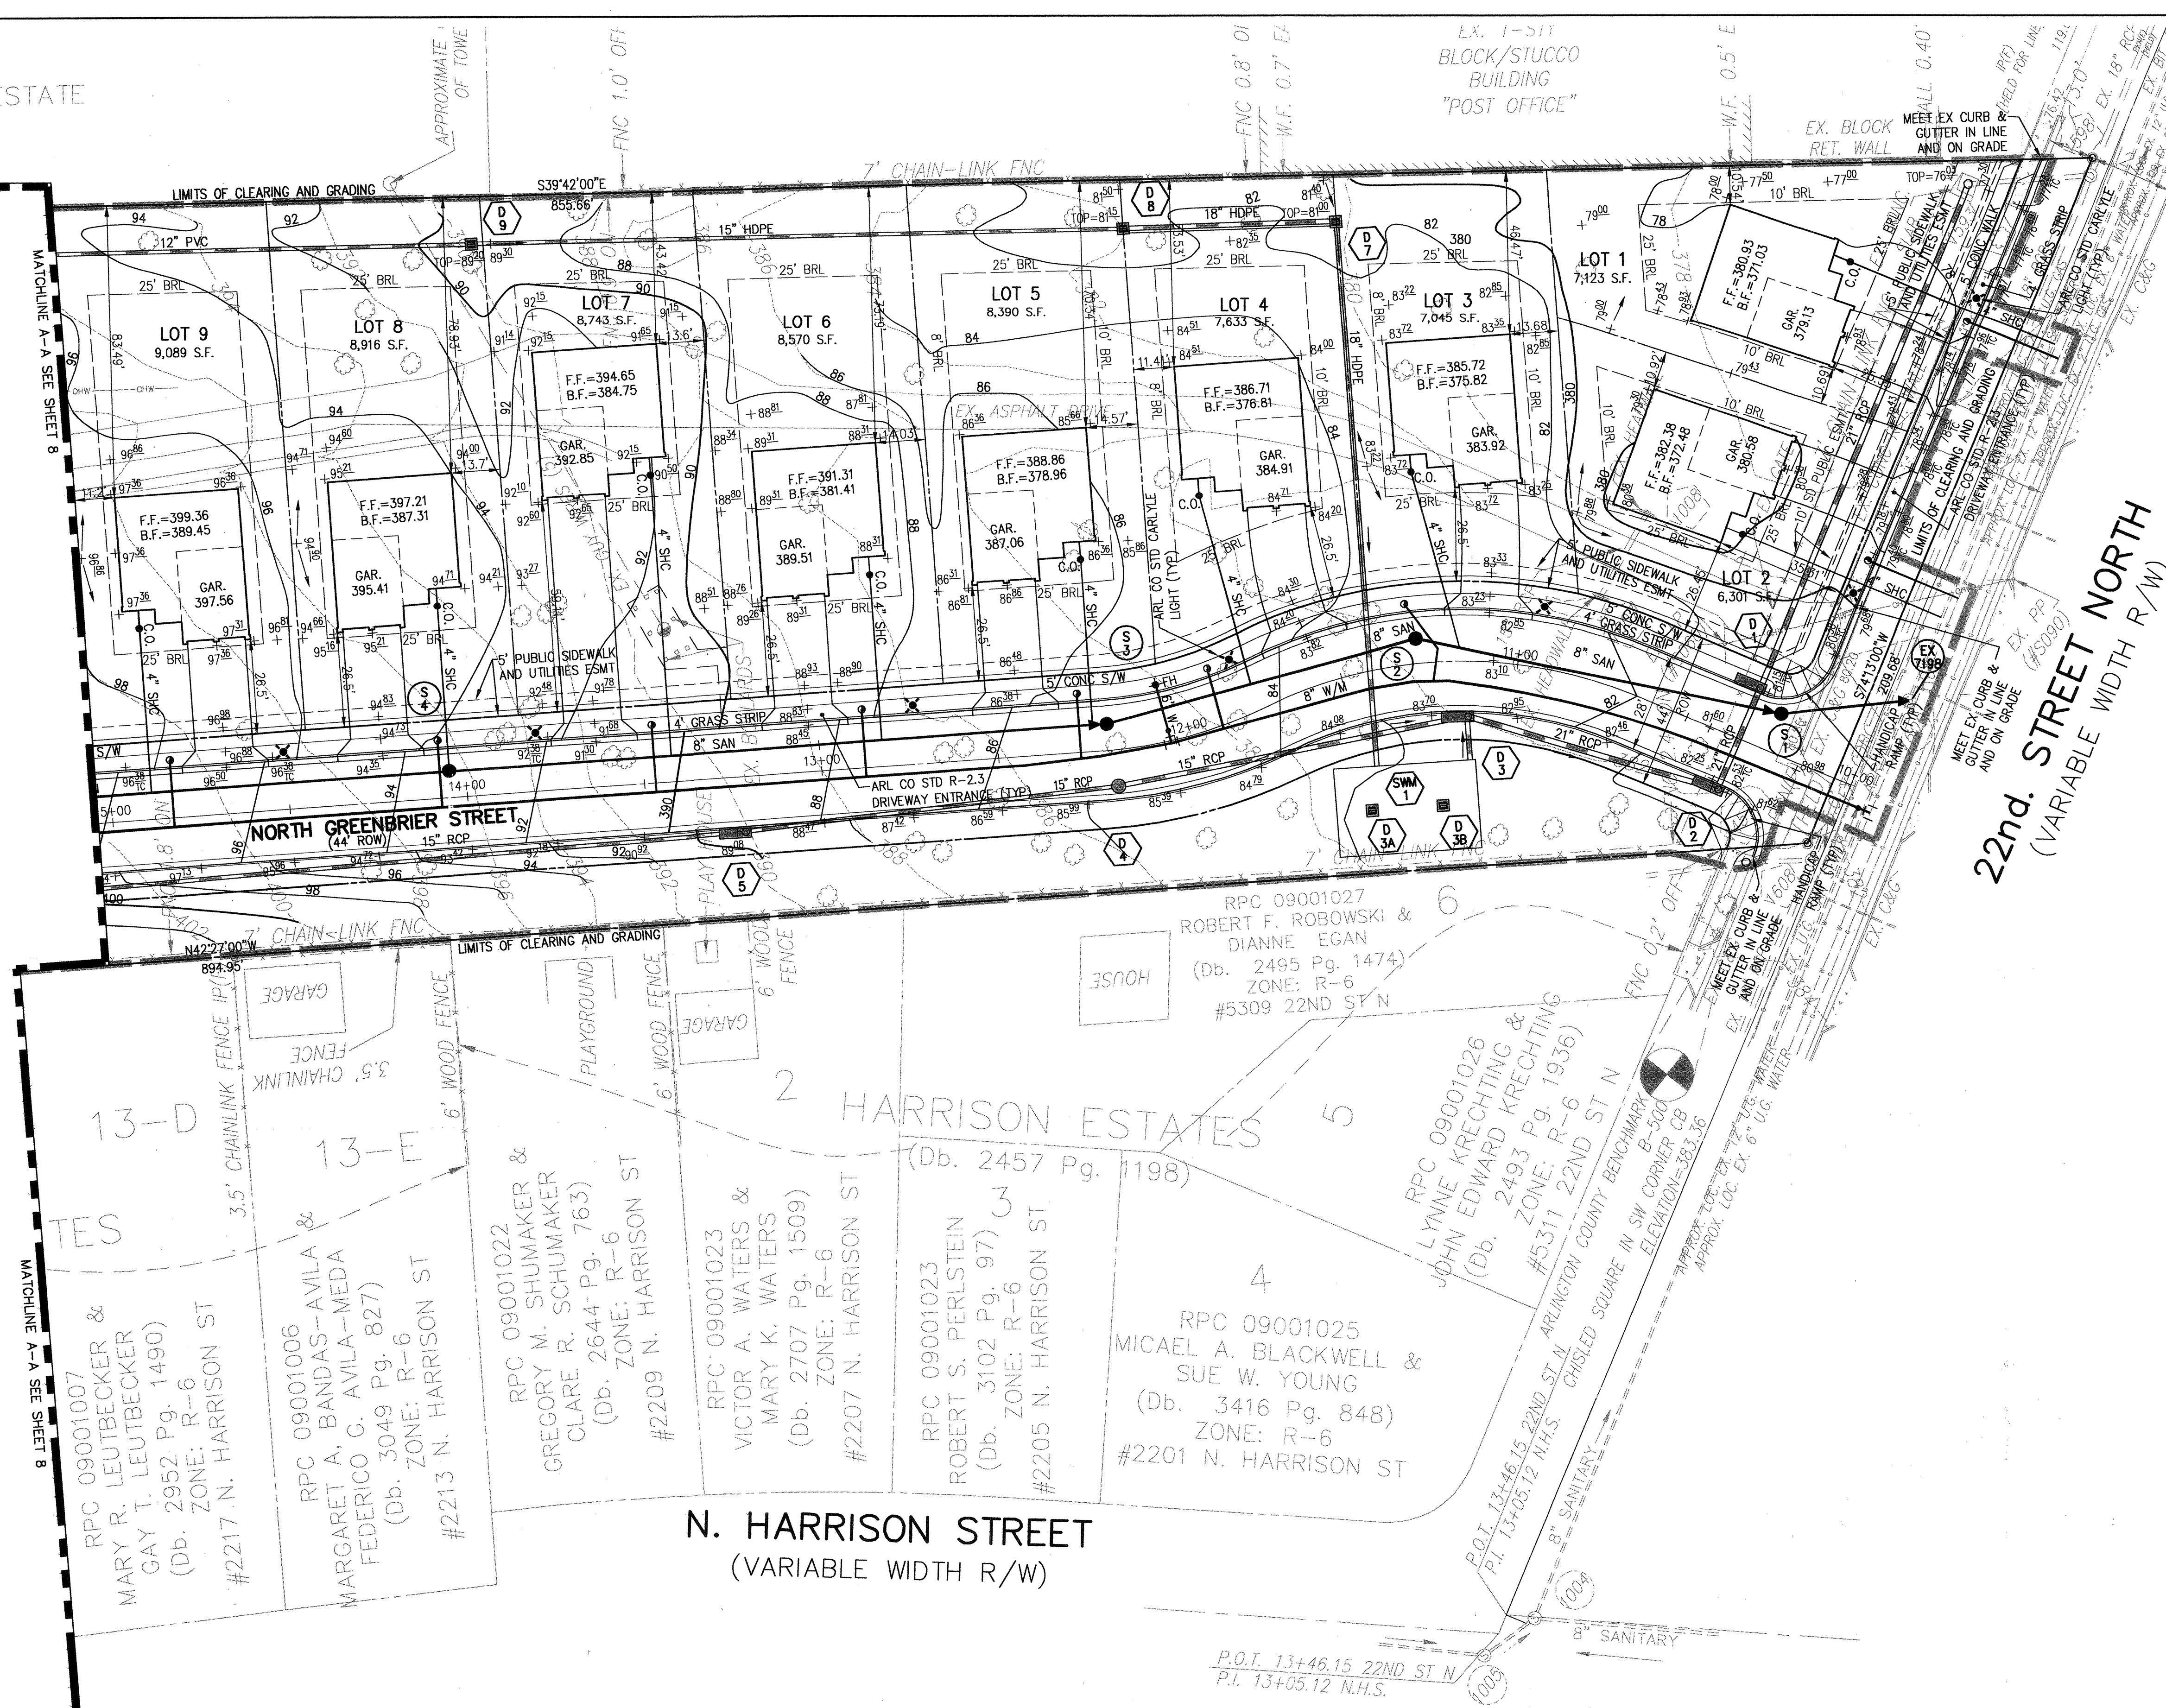



LOT 2-X-2
T.D. DIXON ESTATE
(Db. 1972 Pg. 298)

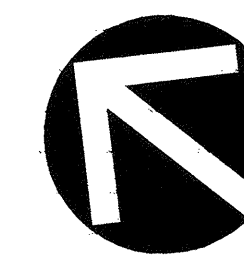

NOTES
WATERMAIN LINSTOPS MAY BE REQUIRED TO
MAINTAIN DOM AND FIRE SERVICE ALONG LEE
HWY DURING SLEEVE-IN PROCEDURE.

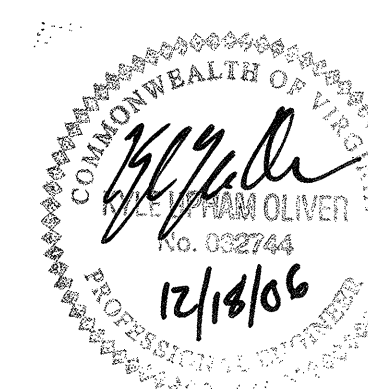

 GRAPHIC SCALE



(IN FEET)
1 inch = 25 ft



ENGINEERS ■ PLANNERS ■ LANDSCAPE ARCHITECTS ■ SURVEYORS ■ CONSTRUCTION INSPECTORS
VIKA INCORPORATED
8180 GREENSBORO DRIVE SUITE 200 ■ McLEAN, VIRGINIA 22102
(703)442-7800 ■ FAX (703)761-2787
McLEAN, VA BETHESDA, MD

ARLINGTON, VIRGINIA
DEPARTMENT OF ENVIRONMENTAL SERVICES

GARDEN COMMONS

22nd ST. NORTH, BTWN. GEORGE MASON DR. AND N. HARRISON ST.

SITE PLAN

SCALE 1" = 25'		DESIGNED <u>SS</u>		CHECKED <u>KUD</u>	
SUBMITTED DATE: APRIL, 2006		APPROVED DATE: <u>2 Jan 2007</u> <u>Mark H. Kellers</u> CHIEF TRANSPORTATION PLANNING BUREAU		APPROVED DATE: <u>1/2/07</u> <u>Patricia Berg</u> CHIEF TRANSPORTATION ENGINEERING BUREAU	
APPROVED DATE: <u>12-22-06</u> <u>Stefan</u> CHIEF WATER, SEWER & STREETS BUREAU		APPROVED DATE: <u>12-27-06</u> <u>Mun</u> CHIEF ENGINEERING BUREAU		APPROVED DATE: <u>1/18/07</u> <u>W. H. H.</u> DIRECTOR OF ENVIRONMENTAL SERVICES	
SHEET 7 OF 20				CONTRACT H— SHEET C-7 OF C-2	

			ARL CO. Mylars 12/15/06
			ARL CO. 3rd. Sub. 10/30/06
			ARL CO. 2nd. Sub. 9/13/06
NO.	DATE	DESCRIPTION	PROJECT/FILE NO.
REVISIONS			6794